

JOSH'S HOUSE

MONITORING SYSTEM DESIGN

LOT 1499 GRIGG PLACE HILTON WA

30/06/2014


SCHEMATIC DESIGN ONLY  
REFER TO GENERAL NOTES, COMPLIANCE  
& INSTALLATION INSTRUCTIONS.

GENERAL NOTES

- GENERAL
- DRAWINGS TO BE READ IN CONJUNCTION WITH ALL OTHER PROJECT, ARCHITECT, ENGINEERS & MANUFACTURERS DOCUMENTATION.
  - ALL SERVICE LINEWORK & ARRANGEMENTS ARE INDICATIVE ONLY & TO BE CONFIRMED ON SITE.
  - PRODUCTS TO BE INSTALLED IN ACCORDANCE WITH MANUFACTURER'S SPECIFICATIONS.


DRAWING SHEET LIST

- MSD-001 COVER PAGE & MONITORING SYSTEM DESIGN OVERALL SITE PLAN
- MSD-101 MONITORING SYSTEM DESIGN - UNIT 1
- MSD-102 MONITORING SYSTEM DESIGN - UNIT 2
- MSD-103 SCHEMATIC SERVICE PLANS - UNIT 2
- MSD-104 EQUIPMENT SCHEDULE

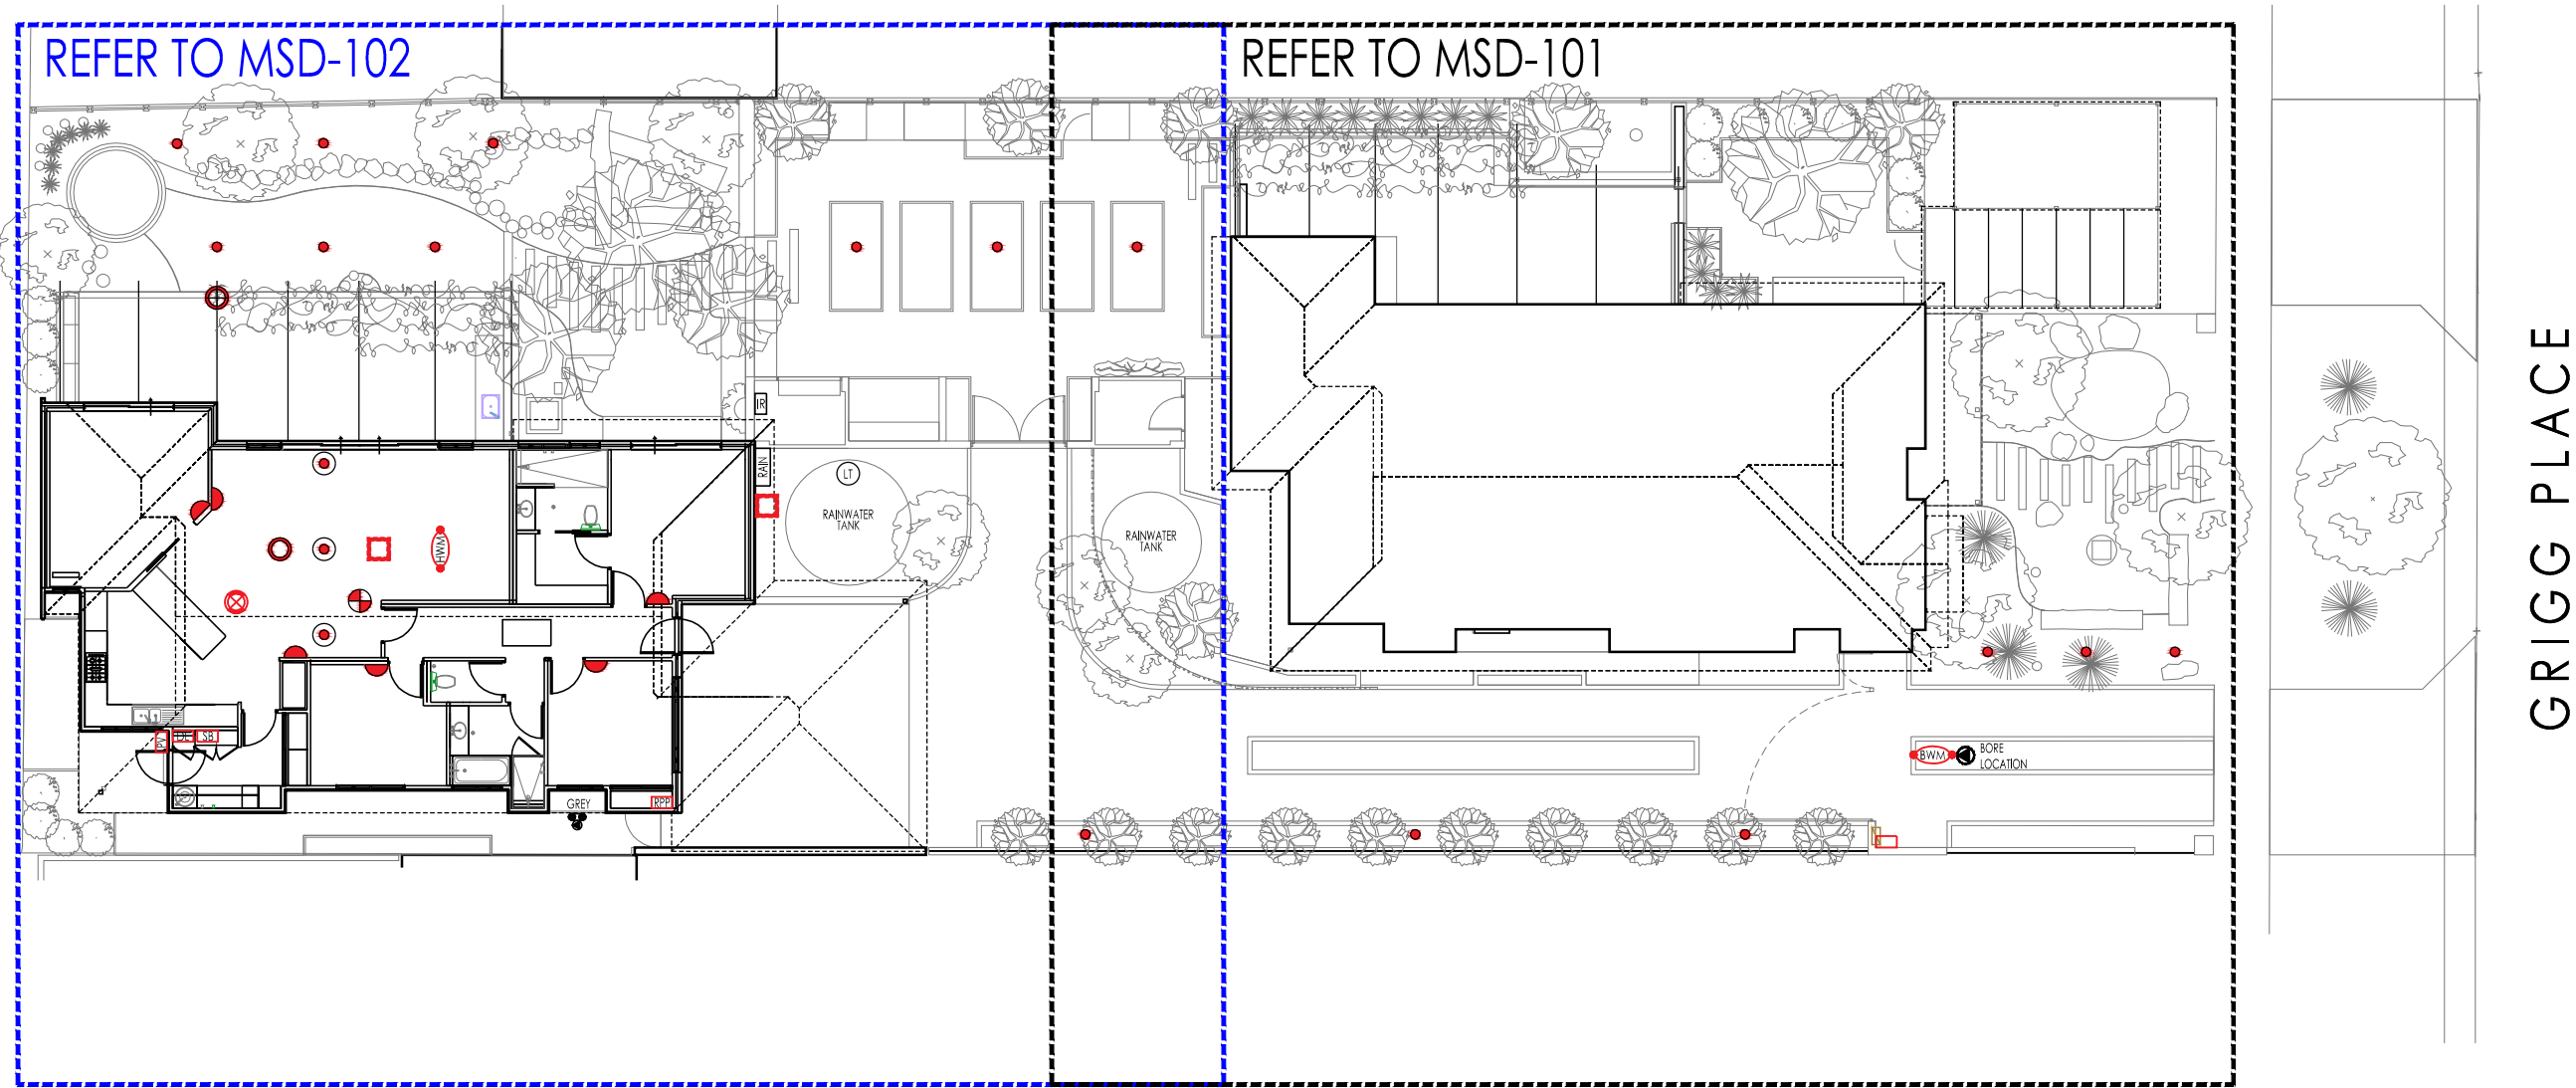

30/06/2014	AS CONSTRUCTED	B
06/05/2013	REVISED FOR CONSTRUCTION	A
02/11/2012	ISSUED FOR CONSTRUCTION	-
DATE	DESCRIPTION	REV

NOTE: CHECK ALL DIMENSIONS ON SITE PRIOR TO COMMENCING WORK. WRITTEN DIMENSIONS SHALL TAKE PRECEDENCE. ALL DRAWINGS TO BE READ IN CONJUNCTION WITH MANUFACTURERS AND CONSULTANTS DOCUMENTATION AND SPECIFICATION. REPORT ANY DISCREPANCIES TO LANDSCAPE DESIGNER BEFORE PROCEEDING WITH WORK.  
COPYRIGHT ©: THIS DOCUMENT HAS BEEN PREPARED FOR USE BY THE RECEIVING CLIENT ONLY. ALL CONCEPTS, DRAWINGS AND TECHNICAL INFORMATION REMAIN THE PROPERTY OF JOSH BYRNE & ASSOCIATES PTY LTD. THIS DOCUMENT CANNOT BE REPRODUCED OR DISTRIBUTED FOR ANY PURPOSE OTHER THAN FOR CONSTRUCTION PURPOSES OF THE SITE DESCRIBED.

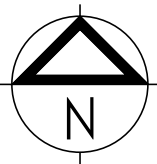

AS CONSTRUCTED


PROJECT TITLE  
JOSH'S HOUSE  
LOT 1499 GRIGG PLACE HILTON WA

DRAWING TITLE  
CONTENTS & MONITORING SYSTEM DESIGN OVERALL SITE PLAN

PROJECT NO. D-00-3	SCALE 1:200	SHEET 1 of 5	REVISION B
CAD FILE PATH --	PLOT DATE 30/06/2014	DWG NO. MSD-001	
DRAWN AB	CHECKED JB	APPROVED JB	

JOSH BYRNE & ASSOCIATES  
Environment • Design • Communication  
phone 08 9433 3721 fax 08 9433 3728  
suite 10, 16 phillimore street fremantle wa 6160  
po box 1866, fremantle wa 6959  
www.joshbyrne.com.au  
jba@joshbyrne.com.au



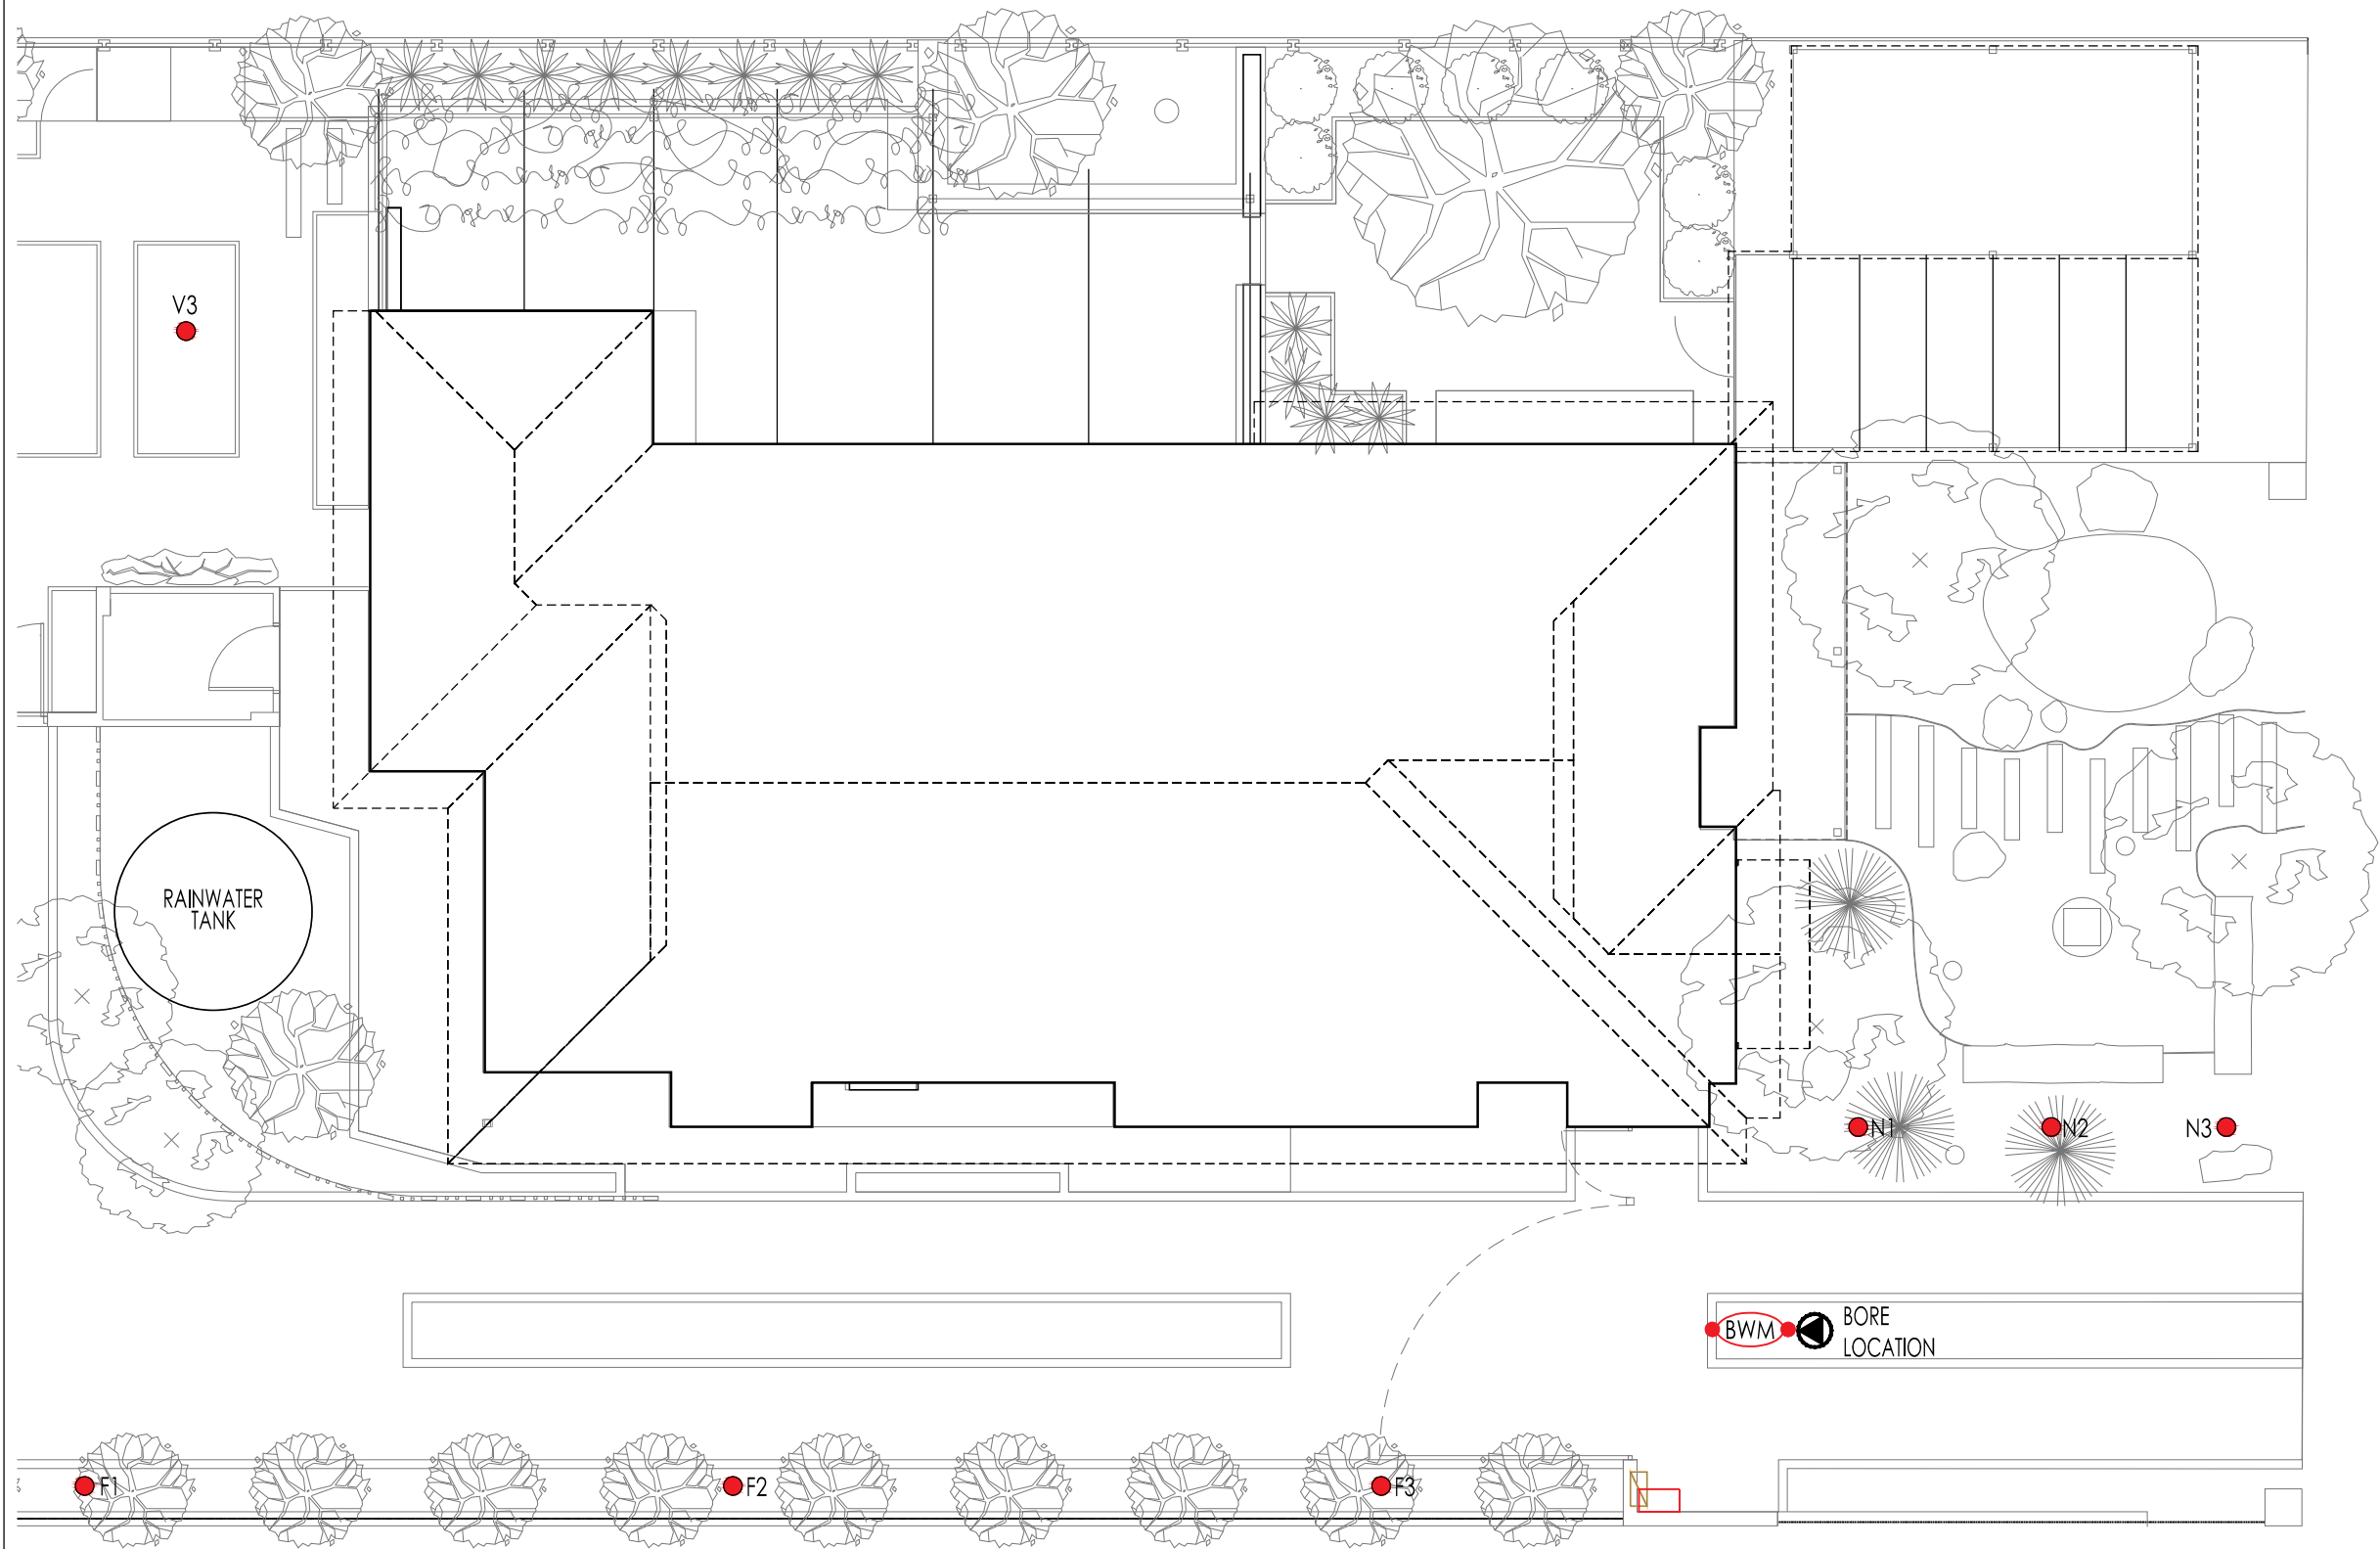

## LEGEND


REFER TO EQUIPMENT & CONNECTIVITY SCHEDULE FOR MORE DETAILS

- SITE BOUNDARY
- ROOF OVERHANG
- SB ELECTRICAL SWITCHBOARD
- DL DATA LOGGING UNIT
- RPP ROUTER & PATCH PANEL
- PV SOLAR PHOTOVOLTAIC (PV) INVERTER
- EM ELECTRICAL SUB METER (INLINE). REFER TO UNIT 2 - SCHEMATIC PLANS & EQUIPMENT SCHEDULE FOR DETAILS
- G1 GAS METER HOUSE SUPPLY
- G2 GAS METER SOLAR HOT WATER SYSTEM SUPPLY
- WM1/6 COLD WATER SUB METERS. REFER TO SCHEMATIC PLANS & EQUIPMENT SCHEDULE FOR DETAILS
- HWM WARM WATER SUB METER. CONNECTED TO UNIT 2 HOT WATER SYSTEM SUPPLY LINE
- BWM BORE WATER METER
- LT WATER LEVEL TRANSMITTER SUBMERSIBLE
- RAIN1 WALL MOUNTED RAINWATER PUMP CABINET, WITH MAINS WATER BACKUP VALVE, PUMP, PRESSURE PUMP & RAINWATER TREATMENT UNIT. REFER TO SCHEMATIC PLAN & EQUIPMENT SCHEDULE FOR DETAILS
- GREY GREYWATER DIVERTER UNIT. REFER TO SCHEMATIC PLAN & EQUIPMENT SCHEDULE FOR DETAILS
- IR IRRIGATION CONTROLLER
- SL1/3 SLAB IN-SITU TEMPERATURE SENSORS
- WA1/6 WALL MOUNTED TEMPERATURE SENSORS
- CE CEILING MOUNTED TEMPERATURE SENSOR
- RC ROOF / CEILING CAVITY MOUNTED TEMPERATURE SENSOR
- RT ROOF SURFACE MOUNTED TEMPERATURE SENSOR
- WS ROOF MOUNTED WEATHER STATION
- GR1/3 SOIL MOISTURE SENSORS - GREYWATER HYDROZONE
- T1/3 SOIL MOISTURE SENSORS - TURF HYDROZONE
- V1/3 SOIL MOISTURE SENSORS - VEGETABLES HYFROZONE
- F1/3 SOIL MOISTURE SENSORS - FRUIT TREES HYDROZONE
- N1/3 SOIL MOISTURE SENSORS - NATIVES HYDROZONE

SITE PLAN - UNIT 1  
SCALE 1:100

30/06/2014	AS CONSTRUCTED	B
06/05/2013	REVISED FOR CONSTRUCTION	A
02/11/2012	ISSUED FOR CONSTRUCTION	-
DATE	DESCRIPTION	REV

**NOTE:** CHECK ALL DIMENSIONS ON SITE PRIOR TO COMMENCING WORK. WRITTEN DIMENSIONS SHALL TAKE PRECEDENCE. ALL DRAWINGS TO BE READ IN CONJUNCTION WITH MANUFACTURERS AND CONSULTANTS DOCUMENTATION AND SPECIFICATION. REPORT ANY DISCREPANCIES TO LANDSCAPE DESIGNER BEFORE PROCEEDING WITH WORK.  
**COPYRIGHT ©:** THIS DOCUMENT HAS BEEN PREPARED FOR USE BY THE RECEIVING CLIENT ONLY. ALL CONCEPTS, DRAWINGS AND TECHNICAL INFORMATION REMAIN THE PROPERTY OF JOSH BYRNE & ASSOCIATES PTY LTD. THIS DOCUMENT CANNOT BE REPRODUCED OR DISTRIBUTED FOR ANY PURPOSE OTHER THAN FOR CONSTRUCTION PURPOSES OF THE SITE DESCRIBED.

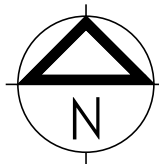

AS CONSTRUCTED

PROJECT TITLE  
**JOSH'S HOUSE**  
**LOT 1499 GRIGG PLACE HILTON WA**

DRAWING TITLE  
MONITORING SYSTEM DESIGN SITE PLAN - UNIT 1

PROJECT NO.  
D-00-3  
CAD FILE PATH  
--

SCALE  
1:100

SHEET  
2 of 5  
PLOT DATE  
30/06/2014

REVISION  
B

 
DRAWN  
AB


CHECKED  
JB

APPROVED  
JB

DWG NO.  
MSD-101

**JOSH BYRNE & ASSOCIATES**  
Environment • Design • Communication  
phone 08 9433 3721 fax 08 9433 3728  
suite 10, 16 phillimore street fremantle wa 6160  
po box 1866, fremantle wa 6959  
www.joshbyrne.com.au  
jba@joshbyrne.com.au



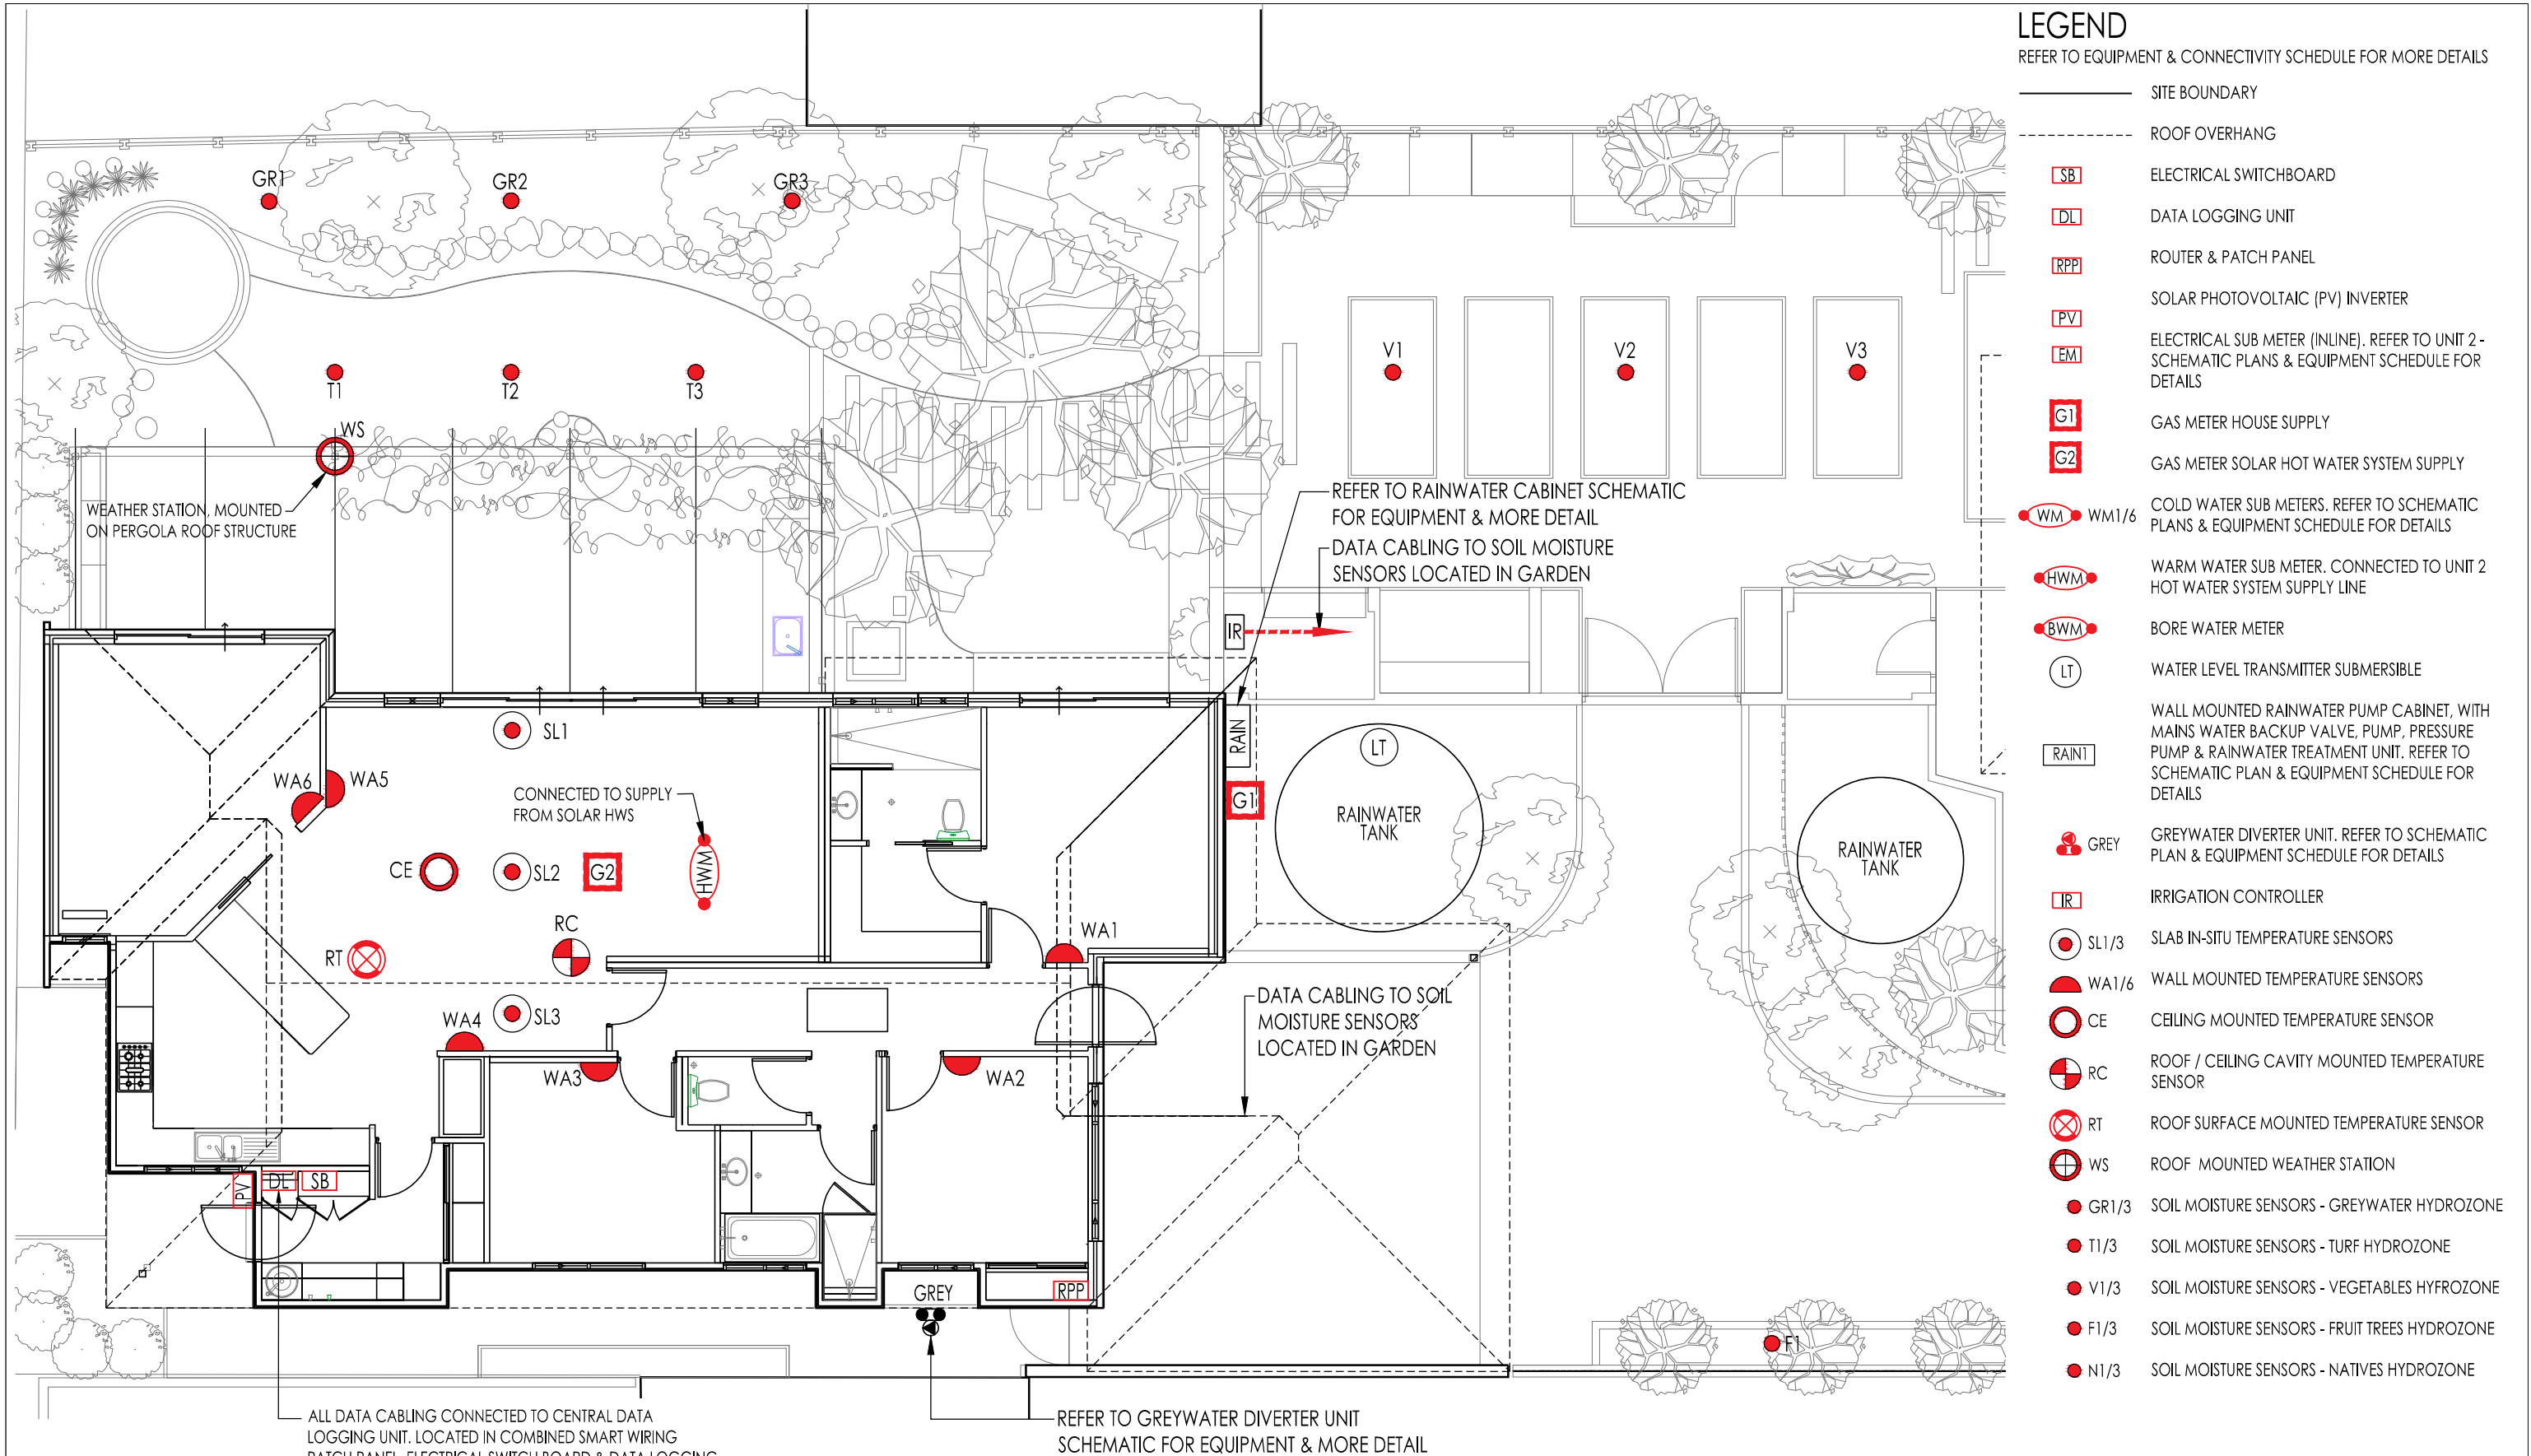

SITE PLAN - UNIT 2  
SCALE 1:100

30/06/2014	AS CONSTRUCTED	B
06/05/2013	REVISED FOR CONSTRUCTION	A
02/11/2012	ISSUED FOR CONSTRUCTION	-
DATE	DESCRIPTION	REV

**NOTE:** CHECK ALL DIMENSIONS ON SITE PRIOR TO COMMENCING WORK. WRITTEN DIMENSIONS SHALL TAKE PRECEDENCE. ALL DRAWINGS TO BE READ IN CONJUNCTION WITH MANUFACTURERS AND CONSULTANTS DOCUMENTATION AND SPECIFICATION. REPORT ANY DISCREPANCIES TO LANDSCAPE DESIGNER BEFORE PROCEEDING WITH WORK.  
**COPYRIGHT ©:** THIS DOCUMENT HAS BEEN PREPARED FOR USE BY THE RECEIVING CLIENT ONLY. ALL CONCEPTS, DRAWINGS AND TECHNICAL INFORMATION REMAIN THE PROPERTY OF JOSH BYRNE & ASSOCIATES PTY LTD. THIS DOCUMENT CANNOT BE REPRODUCED OR DISTRIBUTED FOR ANY PURPOSE OTHER THAN FOR CONSTRUCTION PURPOSES OF THE SITE DESCRIBED.



PROJECT TITLE  
**JOSH'S HOUSE**  
**LOT 1499 GRIGG PLACE HILTON WA**


DRAWING TITLE  
MONITORING SYSTEM DESIGN SITE PLAN - UNIT 2

PROJECT NO. D-00-3	SCALE 1:100	SHEET 3 of 5	REVISION B
CAD FILE PATH --		PLOT DATE 30/06/2014	
DRAWN AB	CHECKED JB	APPROVED JB	DWG NO. MSD-102


**JOSH BYRNE & ASSOCIATES**  
Environment • Design • Communication  
phone 08 9433 3721 fax 08 9433 3728  
suite 10, 16 phillimore street fremantle wa 6160  
po box 1866, fremantle wa 6959  
www.joshbyrne.com.au  
jba@joshbyrne.com.au





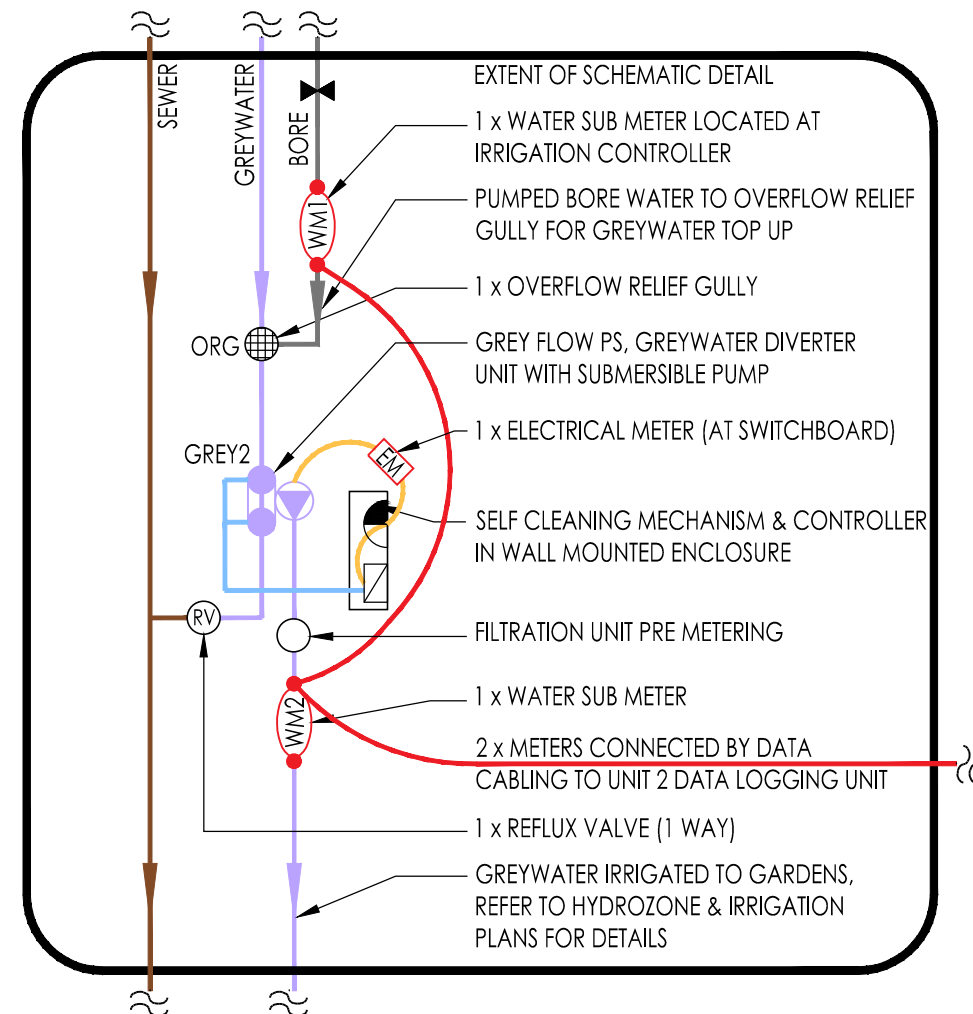

UNIT 2 - GREY2 DIVERTER UNIT SCHEMATIC

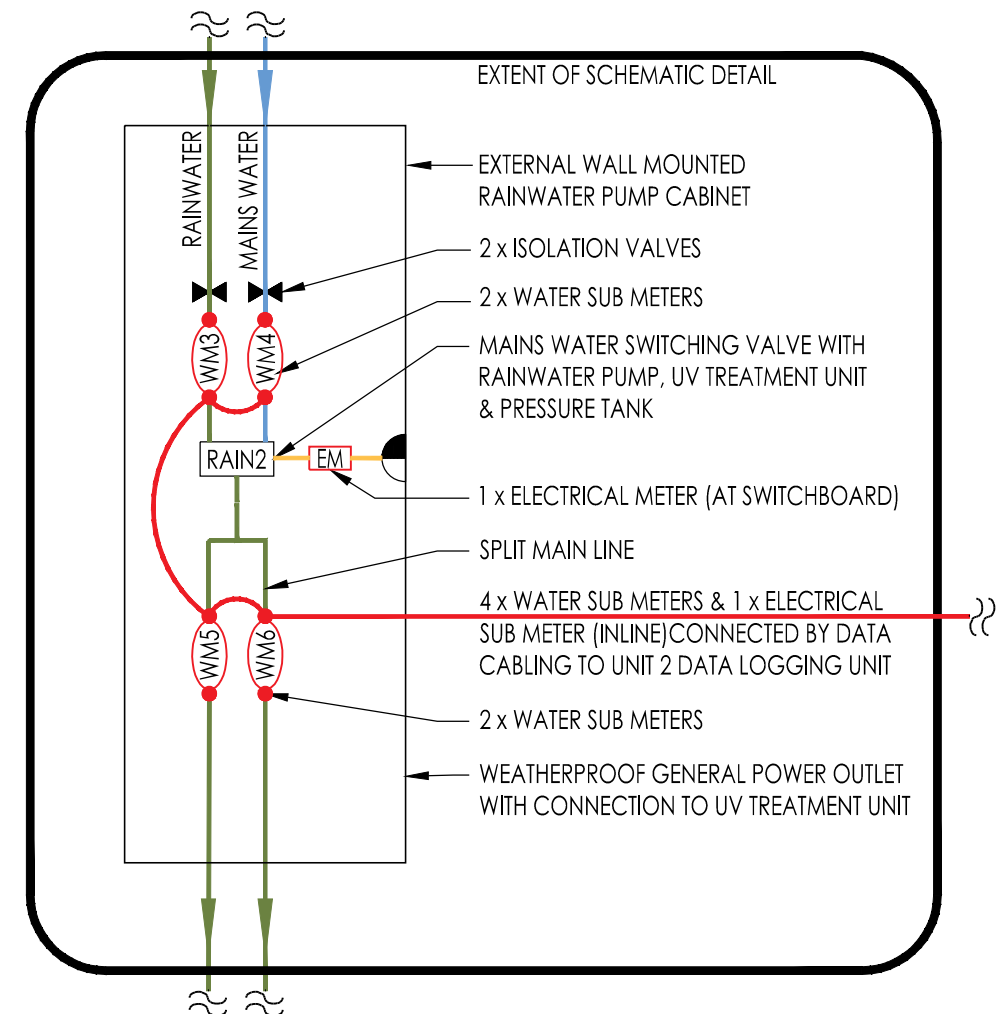

UNIT 2 - WALL MOUNTED RAIN2 CABINET SCHEMATIC

30/06/2014	AS CONSTRUCTED	B
06/05/2013	REVISED FOR CONSTRUCTION	A
02/11/2012	ISSUED FOR CONSTRUCTION	-
DATE	DESCRIPTION	REV

**NOTE:** CHECK ALL DIMENSIONS ON SITE PRIOR TO COMMENCING WORK. WRITTEN DIMENSIONS SHALL TAKE PRECEDENCE. ALL DRAWINGS TO BE READ IN CONJUNCTION WITH MANUFACTURERS AND CONSULTANTS DOCUMENTATION AND SPECIFICATION. REPORT ANY DISCREPANCIES TO LANDSCAPE DESIGNER BEFORE PROCEEDING WITH WORK.

**COPYRIGHT:** THIS DOCUMENT HAS BEEN PREPARED FOR USE BY THE RECEIVING CLIENT ONLY. ALL CONCEPTS, DRAWINGS AND TECHNICAL INFORMATION REMAIN THE PROPERTY OF JOSH BYRNE & ASSOCIATES PTY LTD. THIS DOCUMENT CANNOT BE REPRODUCED OR DISTRIBUTED FOR ANY PURPOSE OTHER THAN FOR CONSTRUCTION PURPOSES OF THE SITE DESCRIBED.




**AS CONSTRUCTED**

PROJECT TITLE  
**JOSH'S HOUSE**  
**LOT 1499 GRIGG PLACE HILTON WA**

DRAWING TITLE  
SCHEMATIC SERVICE PLANS - UNIT 2

PROJECT NO. D-00-3	SCALE N/A	SHEET 3 of 5	REVISION B
CAD FILE PATH --	PLOT DATE 30/06/2014	DWG NO. MSD-103	
DRAWN AB	CHECKED JB	APPROVED JB	

**JOSH BYRNE & ASSOCIATES**  
Environment • Design • Communication  
phone 08 9433 3721 fax 08 9433 3728  
suite 10, 16 phillimore street fremantle wa 6160  
po box 1866, fremantle wa 6959  
www.joshbyrne.com.au  
jba@joshbyrne.com.au

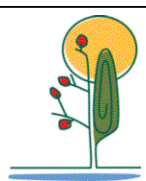



## EQUIPMENT SCHEDULE

QTY	LABEL	ITEM	LOCATION	DESCRIPTION
1	DL	DATA LOGGING UNIT	LAUNDRY SWICH BOARD CABINET	DATATAKER DT80 DATA LOGGING UNIT WITH CHANNEL EXPANSION MODULE
1	RPP	ROUTER & PATCH PANEL	BEDROOM 2 CABINET	ROUTER LOCATION & PATCH PANEL
1	SB	ELECTRICAL SWITCH BOARD	LAUNDRY SWICH BOARD CABINET	ELECTRICAL SWITCH BOARD
1	G1	GAS METER	EAST SIDE OF HOUSE - REFER DRAWINGS	AMPY750 VOLUMETRIC GAS METER (HOUSE SUPPLY)
1	G2	GAS METER	ROOF CAVITY - REFER DRAWINGS	AMPY750 VOLUMETRIC GAS METER (SOLAR HOT WATER SYSTEM SUPPLY)
11	EM1/11	ELECTRICAL CIRCUIT METERS	ELECTRICAL SWITCH BOARD	11 X LATRONICS KWHR METERS (4 X GPO CIRCUITS; 2 X LIGHTING / FAN CIRCUITS; 1 X OVEN CIRCUIT; 1 X GREYWATER PUMP CIRCUIT, 1 X BORE PUMP CIRCUIT; RAINWATER PUMPCIRCUIT; 1 X PV FEED CIRCUIT)
1	WSA	RAIN GAUGE	PERGOLA - REFER DRAWINGS	VAISALA WXT520 WEATHER STATION
1	WSB	WIND SPEED & DIRECTION SENSOR	PERGOLA - REFER DRAWINGS	VAISALA WXT520 WEATHER STATION
1	WSC	SOLAR RADIATOR SENSOR	PERGOLA - REFER DRAWINGS	VAISALA WXT520 WEATHER STATION
1	WSD	TEMPERATURE & RELATIVE HUMIDITY SENSORS	PERGOLA - REFER DRAWINGS	VAISALA WXT520 WEATHER STATION
3	SL1/3	SLAB IN-SITU TEMPERATURE SENSORS	LIVING ROOM - REFER TO DRAWINGS	TCKPP120 20AWG THERMOCOUPLE WIRE, CAST INTO SLAB
6	WA1/6	WALL TEMPERATURE SENSORS	INTERNAL WALLS - REFER TO DRAWINGS	TCKPP120 20AWG THERMOCOUPLE WIRE
1	CE	CEILING TEMPERATURE SENSOR	LIVING ROOM - REFER TO DRAWINGS	TCKPP120 20AWG THERMOCOUPLE WIRE
1	RC	ROOF CAVITY TEMPERATURE SENSOR	ATTIC - REFER TO DRAWINGS	TCKPP120 20AWG THERMOCOUPLE WIRE
1	RT	ROOF MOUNTED TEMPERATURE SENSOR	ROOF - REFER TO DRAWINGS	TCKPP120 20AWG THERMOCOUPLE WIRE, CONNECTED TO ROOF SHEETING
3	GR1/3	SOIL MOISTURE SENSORS - GREYWATER HYDROZONE	LANDSCAPE - REFER TO DRAWINGS	DECAGON 10HS CAPACITANCE SOIL MOISTURE PROBES
3	T1/3	SOIL MOISTURE SENSORS - TURF HYDROZONE	LANDSCAPE - REFER TO DRAWINGS	DECAGON 10HS CAPACITANCE SOIL MOISTURE PROBES
3	V1/3	SOIL MOISTURE SENSORS - VEGETABLES HYDROZONE	LANDSCAPE - REFER TO DRAWINGS	DECAGON 10HS CAPACITANCE SOIL MOISTURE PROBES
3	F1/3	SOIL MOISTURE SENSORS - FRUIT TREES HYDROZONE	LANDSCAPE - REFER TO DRAWINGS	DECAGON 10HS CAPACITANCE SOIL MOISTURE PROBES
6	N1/6	SOIL MOISTURE SENSORS - NATIVE HYDROZONE	LANDSCAPE - REFER TO DRAWINGS	DECAGON 10HS CAPACITANCE SOIL MOISTURE PROBES
6	WM1/6	COLD WATER METERS	VARIOUS - REFER TO DRAWINGS	20MM ELSTER V100 COLD WATER METERS
1	BWM	BORE WATER METER	DRIVEWAY - REFER DRAWINGS	40MM MT-EX SERIES WATER METER
1	HWM	HOT WATER METER	ROOF CAVITY - REFER TO DRAWING	20MM KENT S130 WARM WATER METERS
1	LT	LEVEL TRANSMITTER (TANK)	TANK - REFER TO DRAWINGS	MERCOID SERIES SBLT2 SUBMERSIBLE LEVEL TRANSMITTERS

30/06/2014	AS CONSTRUCTED	B
06/05/2013	REVISED FOR CONSTRUCTION	A
02/11/2012	ISSUED FOR CONSTRUCTION	-
DATE	DESCRIPTION	REV

**NOTE:** CHECK ALL DIMENSIONS ON SITE PRIOR TO COMMENCING WORK. WRITTEN DIMENSIONS SHALL TAKE PRECEDENCE. ALL DRAWINGS TO BE READ IN CONJUNCTION WITH MANUFACTURERS AND CONSULTANTS DOCUMENTATION AND SPECIFICATION. REPORT ANY DISCREPANCIES TO LANDSCAPE DESIGNER BEFORE PROCEEDING WITH WORK.

**COPYRIGHT ©:** THIS DOCUMENT HAS BEEN PREPARED FOR USE BY THE RECEIVING CLIENT ONLY. ALL CONCEPTS, DRAWINGS AND TECHNICAL INFORMATION REMAIN THE PROPERTY OF JOSH BYRNE & ASSOCIATES PTY LTD. THIS DOCUMENT CANNOT BE REPRODUCED OR DISTRIBUTED FOR ANY PURPOSE OTHER THAN FOR CONSTRUCTION PURPOSES OF THE SITE DESCRIBED.

AS CONSTRUCTED

0 1 2 3 4 5

PROJECT TITLE	PROJECT NO.	SCALE	SHEET	REVISION
JOSH'S HOUSE	D-00-3	N/A	4 of 5	B
LOT 1499 GRIGG PLACE HILTON WA	CAD FILE PATH	PLOT DATE		
	---	30/06/2014		
DRAWING TITLE	DRAWN	CHECKED	APPROVED	DWG NO.
EQUIPMENT SCHEDULE	AB	JB	JB	MSD-104

**JOSH BYRNE & ASSOCIATES**  
 Environment • Design • Communication  
 phone 08 9433 3721 fax 08 9433 3728  
 suite 10, 16 phillimore street fremantle wa 6160  
 po box 1866, fremantle wa 6959  
[www.joshbyrne.com.au](http://www.joshbyrne.com.au)  
[jba@joshbyrne.com.au](mailto:jba@joshbyrne.com.au)

